


© This drawing is Copyright and the property of Cruden Homes (East) Ltd  
It may not be reproduced or disclosed to a third party without written consent.

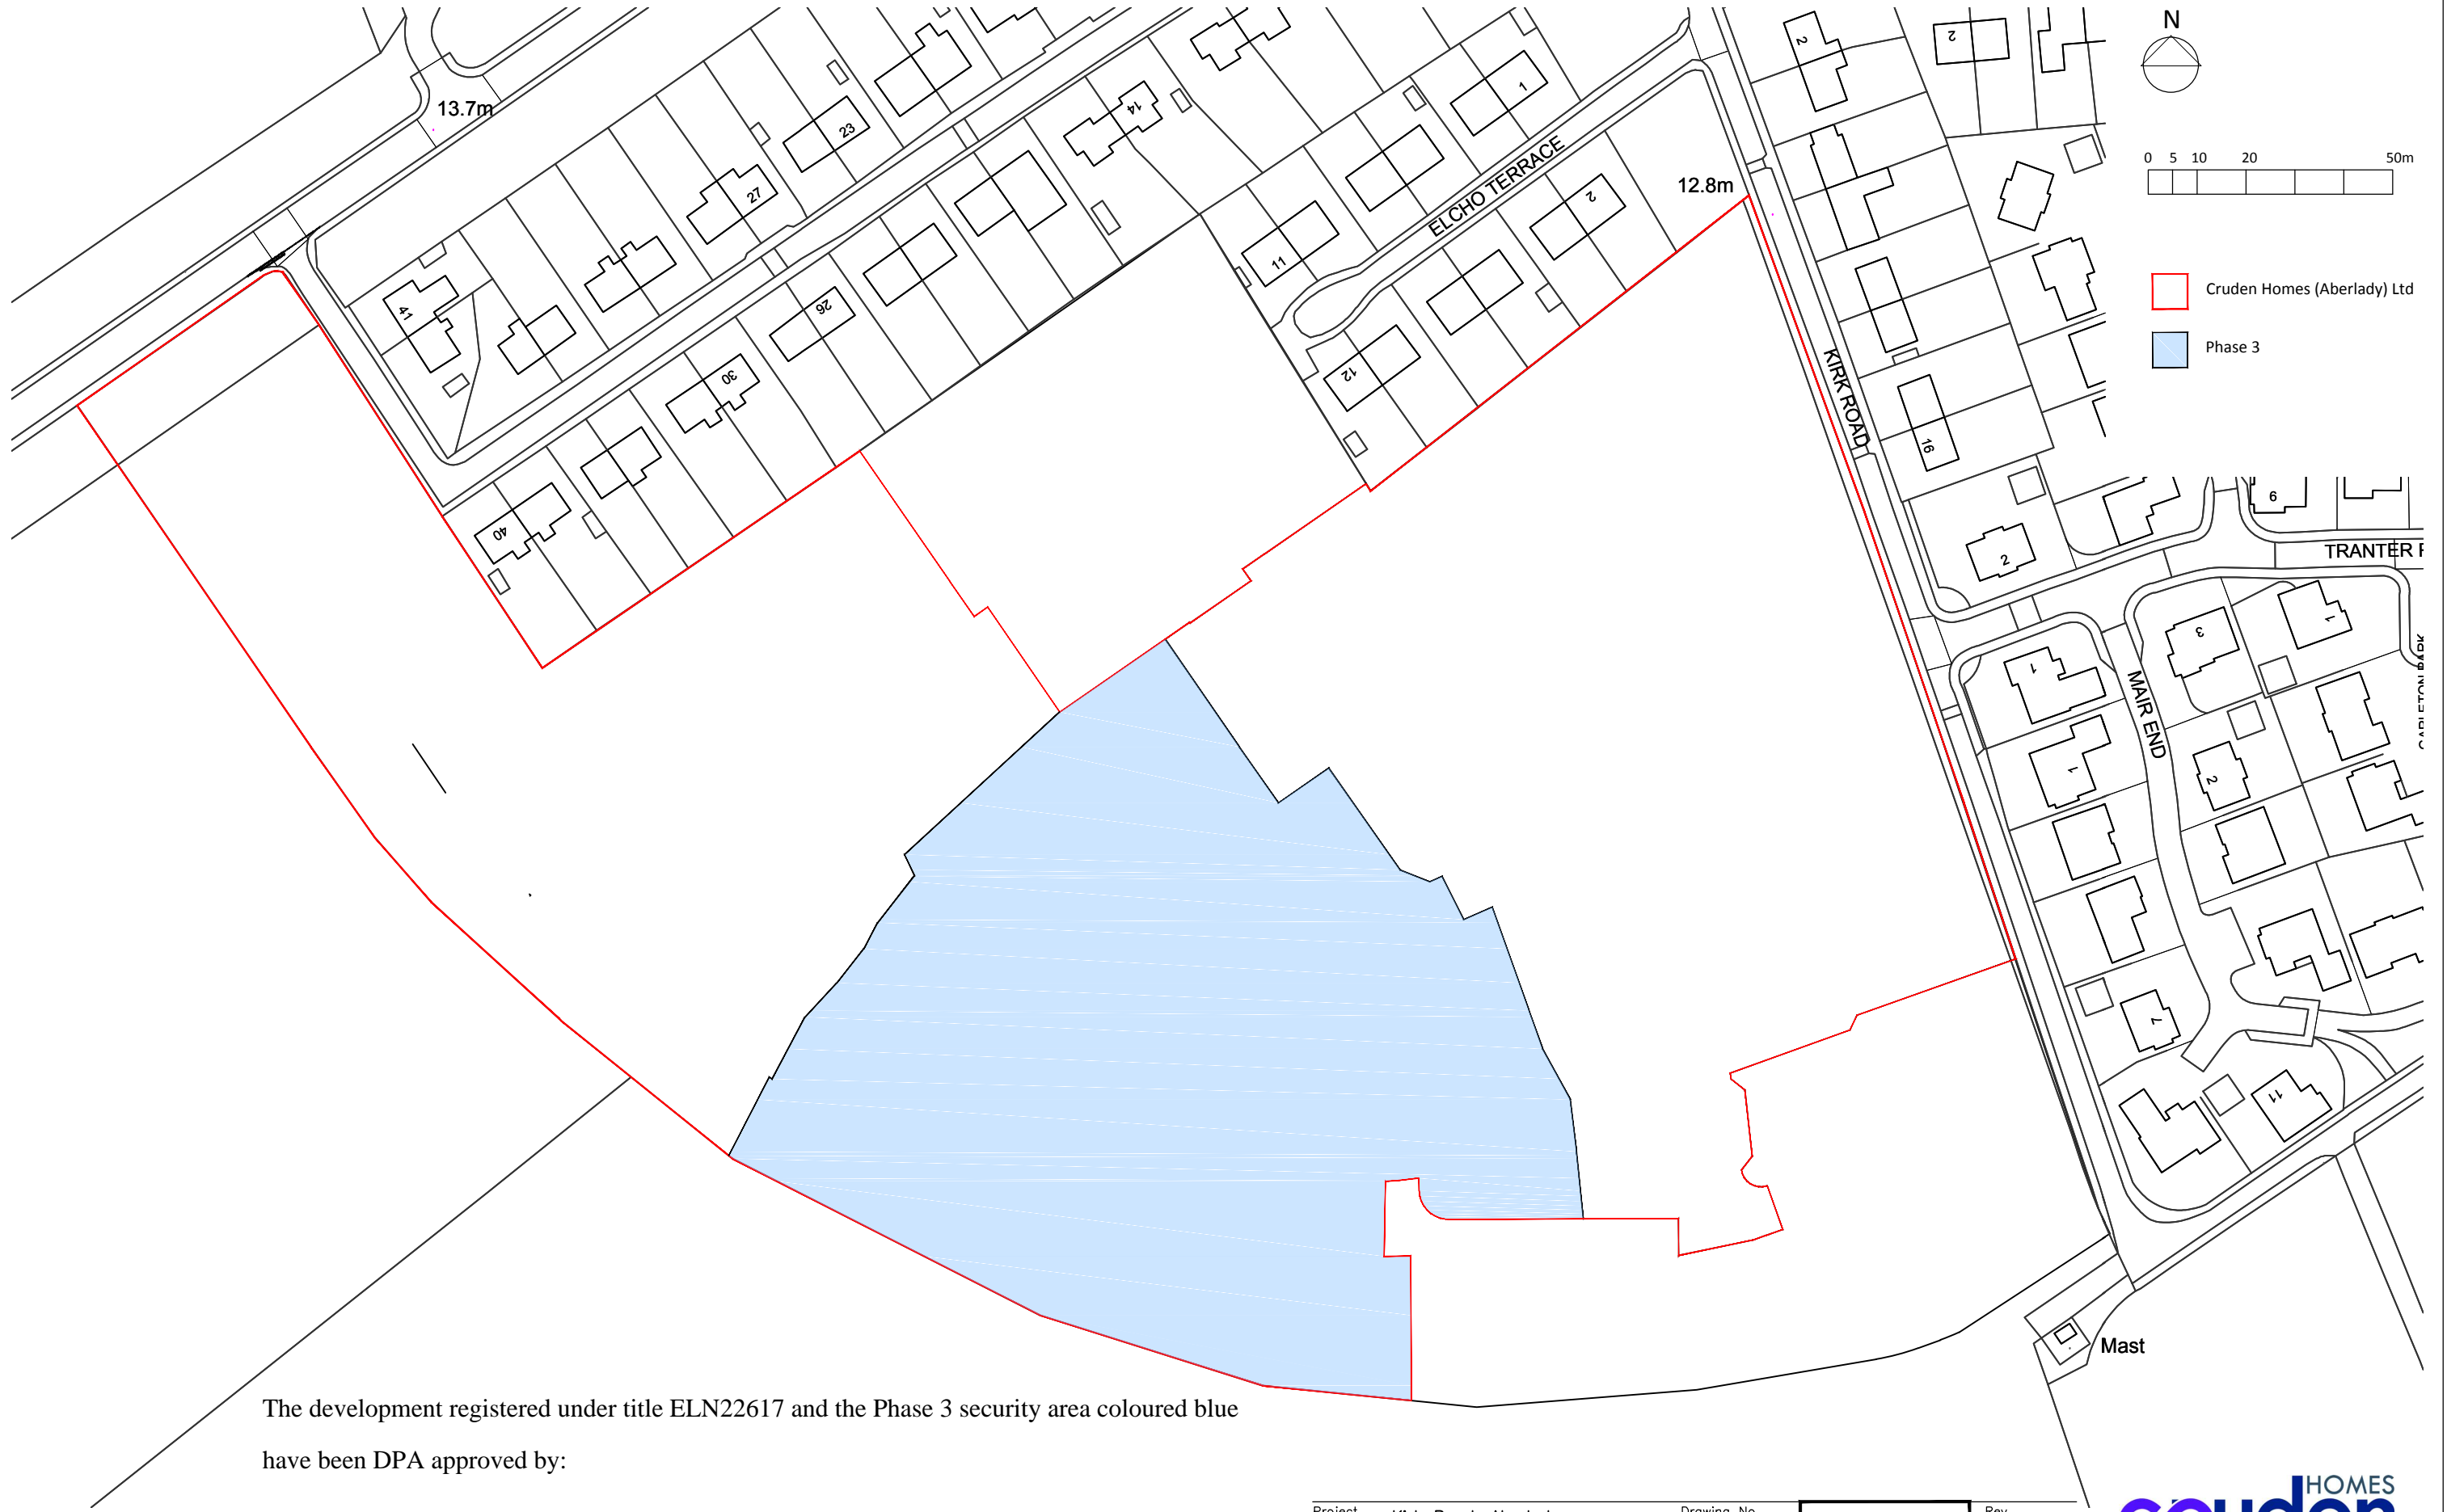

The development registered under title ELN22617 and the Phase 3 security area coloured blue

have been DPA approved by:

*S Pardue - 28th November 2018*

Stuart Pardue (DPA officer)

Project	Kirk Road, Aberlady	Drawing No.	1626(LG)010	Rev	-
Drawing	Phase 3 Security Plan	Status	INFORMATION		
Scale	1:1250 © A3	Drawn	KH	Date	26/11/18

**cruden** HOMES  
Firm foundations, flexible living  
CRUDEN HOMES (EAST) LIMITED  
CRUDEN HOUSE, 36 SOUTH GYLE CRESCENT,  
EDINBURGH, EH12 9EB TEL 0131 285 6600